

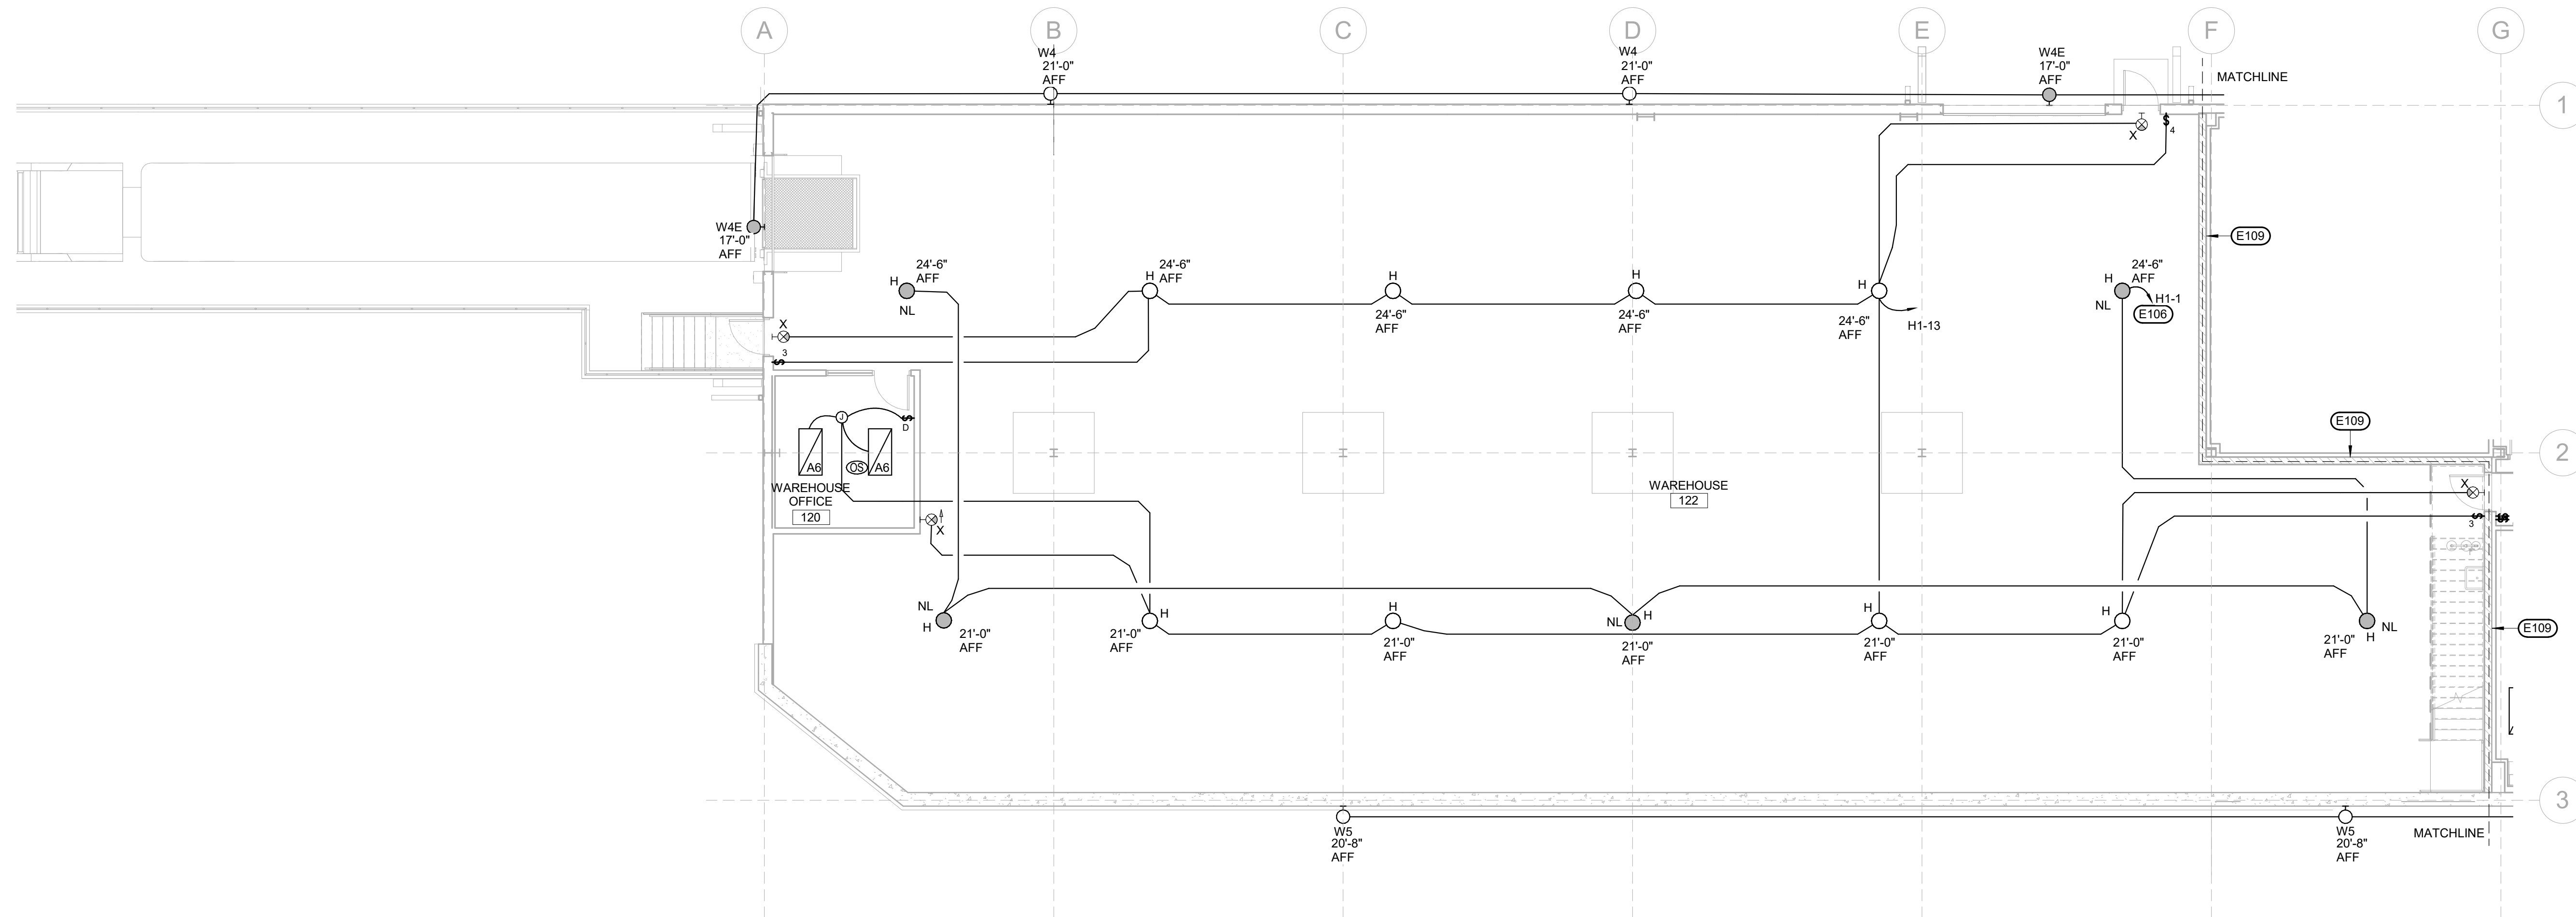


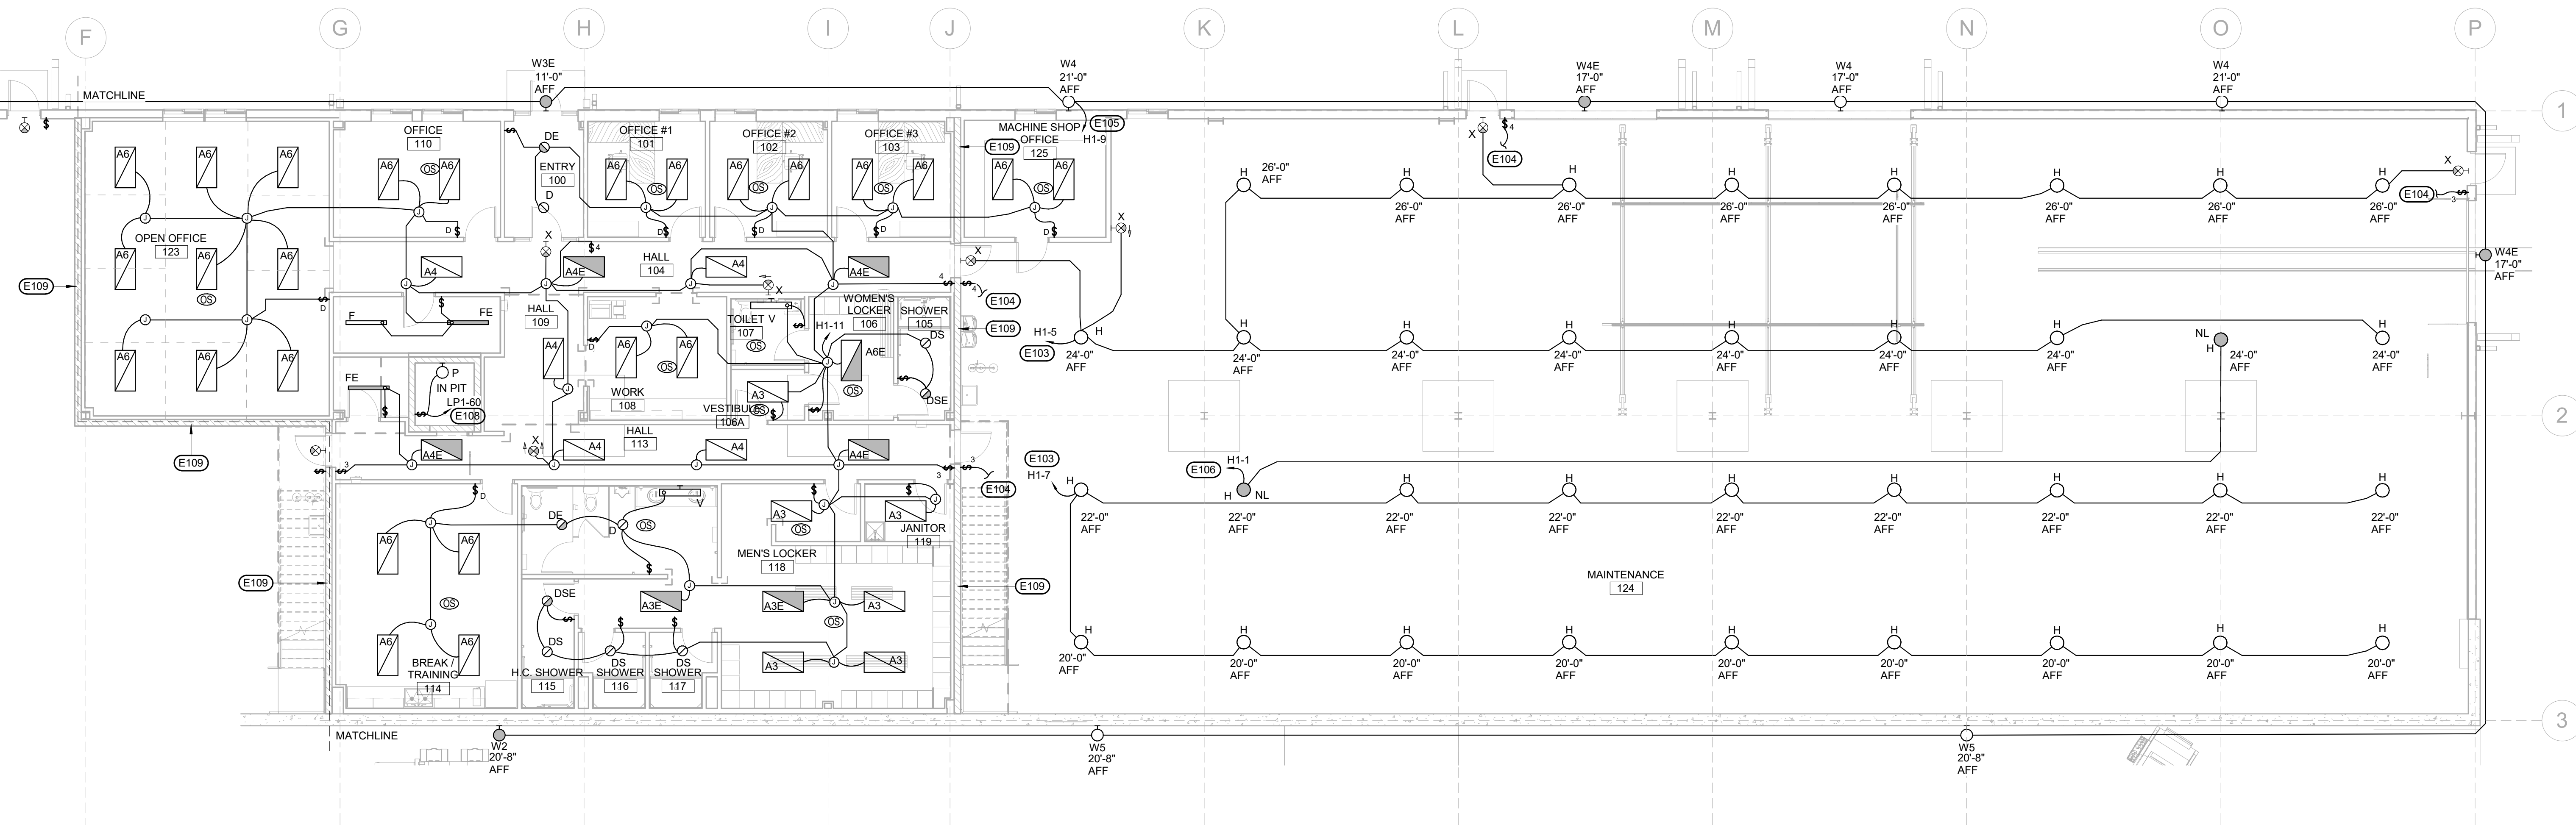


MAIN LEVEL LIGHTING PLAN - WEST

SCALE: 1/8" = 1'-0"

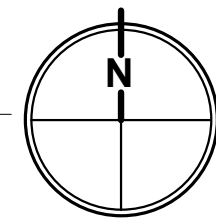

MAIN LEVEL LIGHTING PLAN - EAST

SCALE: 1/8" = 1'-0"

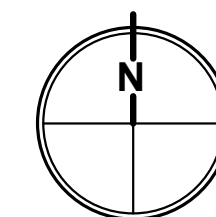


ELECTRICAL MISCELLANEOUS NOTES

- A THE HIGHBAY LIGHT FIXTURES IN WAREHOUSE 124 AND MACHINE SHOP 125 ARE TO BE MOUNTED AT LEVEL OF THE BOTTOM OF THE STRUCTURE JOISTS. CONTRACTOR TO PROVIDE UNISTRUT AS NECESSARY FOR PROPER FIXTURE PLACEMENT.
- B LIGHT FIXTURES WITH NOTATION "NL" SHALL BE WIRED TO BE UNSWITCHED (POWERED ALL THE TIME) AND SERVE AS NIGHT LIGHTS.
- C ELECTRICAL WORK ASSOCIATED WITH THE #1. BASE BID SHALL INCLUDE CIRCUIT BREAKERS, CONDUIT ROUGH-IN, AND BOX ROUGH-IN FOR FUTURE ELEVATOR PIT LIGHT, FUTURE ELEVATOR PIT SUMP PUMP RECEPTACLE, AND FUTURE ELEVATOR PIT SUMP PUMP RECEPTACLE. BID ALTERNATE #1 WILL INCLUDE ALL ELEVATOR POWER CONNECTIONS, ELEVATOR LIGHT CONNECTIONS, SHUNT-TRIP DISCONNECT, ASSOCIATED SAFETY DISCONNECT SWITCHES, PIT LIGHT, SUMP PUMP, PIT SERVICE RECEPTACLE, AND FIRE ALARM PROVISIONS.

ELECTRICAL SPECIFIC NOTES

- E103 THIS CIRCUIT IS TO BE ROUTED THROUGH INTERIOR LIGHTING CONTROL. REFER TO INTERIOR LIGHTING CONTROL DIAGRAM.
- E104 THIS SWITCH IS TO BE ROUTED THROUGH THE INTERIOR LIGHTING CONTROL FOR CONTROL OF HIGH-BAY FIXTURES IN MAINTENANCE 123. REFER TO INTERIOR LIGHTING CONTROL DIAGRAM.
- E105 THIS CIRCUIT IS TO BE ROUTED THROUGH EXTERIOR LIGHTING CONTROL. REFER TO EXTERIOR LIGHTING CONTROL DIAGRAM.
- E106 THIS LIGHTING CIRCUIT IS TO BE ROUTED THROUGH LIGHTING INVERTER LOCATED IN ELECTRICAL/DATA ROOM.
- E108 PROVIDE 208V, 30A, 3 POLE SAFETY DISCONNECT SWITCH IN ELEVATOR EQUIPMENT ROOM. THIS SWITCH SHALL SIMULTANEOUSLY DISCONNECT POWER TO THREE CIRCUITS: ELEVATOR PIT LIGHT CIRCUIT, ELEVATOR PIT RECEPTACLE CIRCUIT, AND SUMP PUMP PIT RECEPTACLE CIRCUIT.
- E109 FIRE-RATED WALL THAT WILL REQUIRE ALL PENETRATIONS TO BE PROPERLY SEALED WITH PROPERLY RATED FIRE SEALANT.

WILLIAMS & ASSOCIATES ARCHITECTURE, INC.
125 E. Colorado Blvd., Suite 2A Spearfish, South Dakota 57783
Phone: (605) 642-2009 | Fax: (605) 642-3339

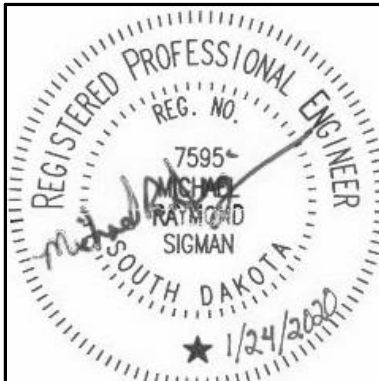

THESE DRAWINGS AND THE DESIGNS HERE ILLUSTRATED ARE THE SOLE PROPERTY OF WILLIAMS & ASSOCIATES ARCHITECTURE, INC. AND MAY NOT BE REPRODUCED IN WHOLE OR IN PART WITHOUT EXPRESS WRITTEN PERMISSION.

COPYRIGHT 1

Project Title
MAINTENANCE SUPPORT FACILITY
630 E Summit St., Lead, SD 57754

Project No. BR19022
Issue Date 1/24/2020
Print Stamp 1/24/2020 7:09:19 AM
Designed By MRS
Drawn By VLS

Revision Schedule

Revision	Date

Verification Bar Scale: 1/8" = 1'-0"

PLEASE USE THIS BAR SCALE TO CONFIRM THAT THE DIGITAL OR HARDCOPY REPRODUCTION OF THIS SHEET IS AT THE CORRECT SCALE.




Sheet

MAIN LEVEL
LIGHTING PLAN

Sheet

E2.10


WPE WEST PLAINS ENGINEERING, INC.
1750 RAND ROAD • RAPID CITY SD, 57702
PHONE: (605) 348-7455 • FAX: (605) 348-9445
WWW.WESTPLAINSENGINEERING.COM
RAPID CITY, SD • SIOUX FALLS, SD • CASPER, WY • CEDAR RAPIDS, IA • BISMARCK, ND

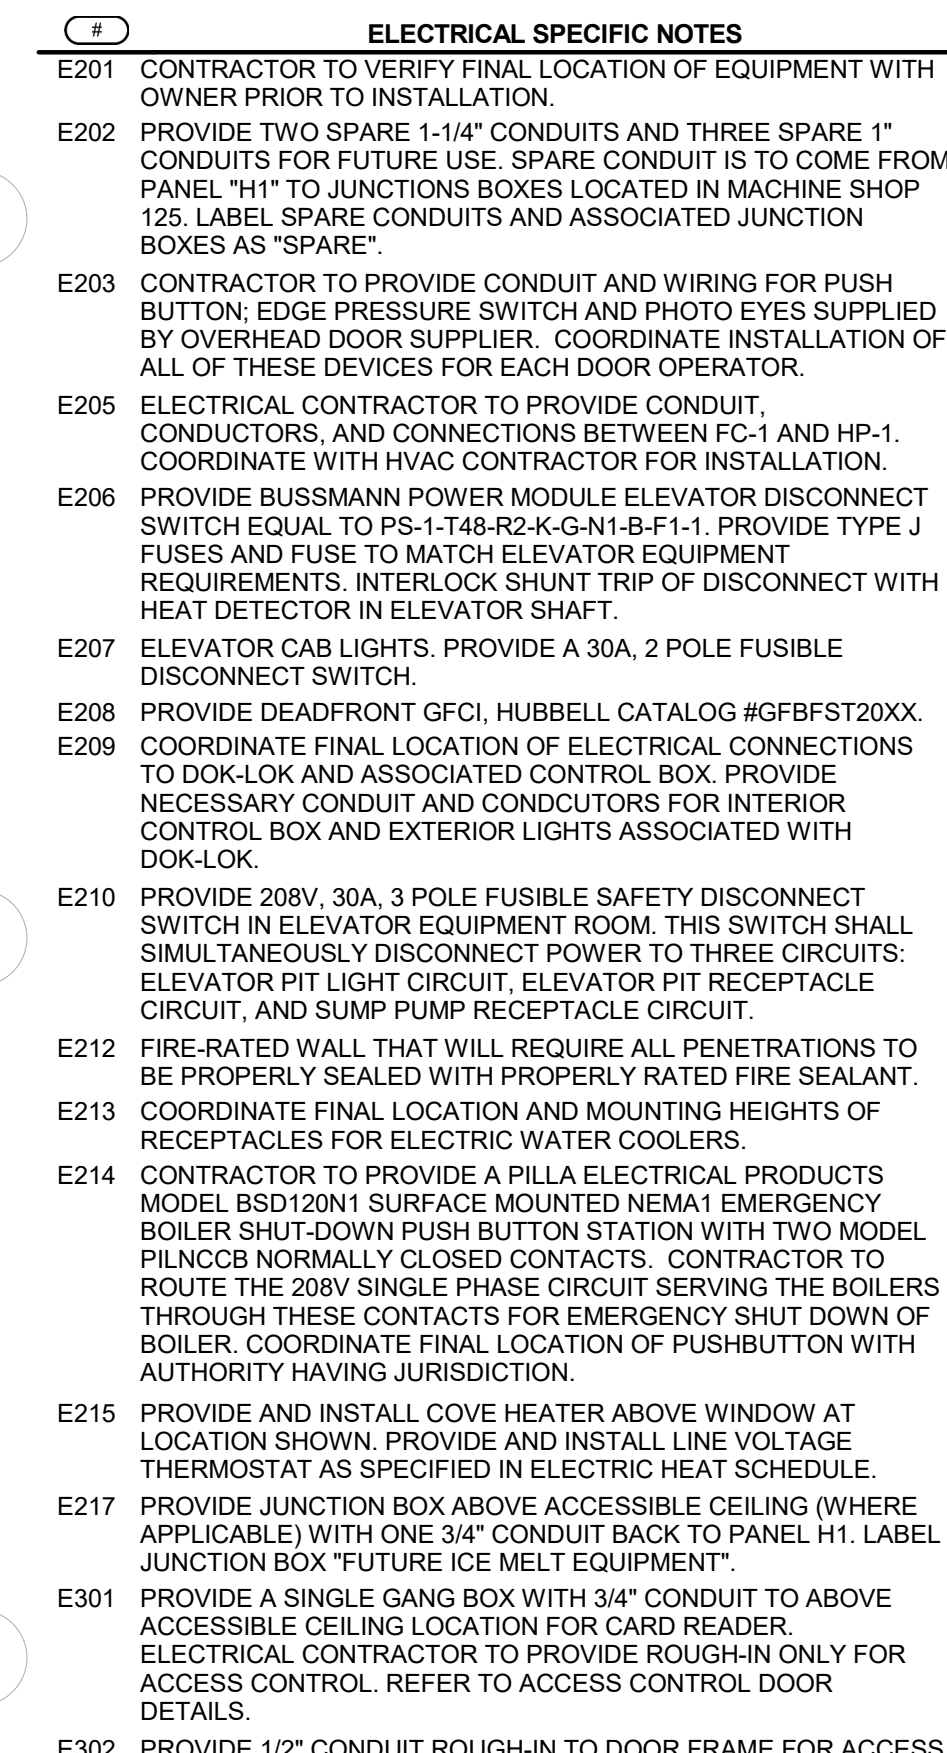

ELECTRICAL MISCELLANEOUS NOTES

PROVIDE A JUNCTION BOX AT ROUTE AND PROVIDE A CAT-6 CABLE BAC LABEL AT EACH END. COORDINATE WITH OWNER. ELECTRICAL CONTRACTOR ONLY; OWNER TO HIRE SEPARATE TERMINATIONS.

WPE WEST PLAINS ENGINEERING, INC.
1750 RAND ROAD • RAPID CITY SD, 57702
PHONE: (605) 348-7455 • FAX: (605) 348-9445
WWW.WESTPLAINSENGINEERING.COM
RAPID CITY, SD • SIOUX FALLS, SD • CASPER, WY • CEDAR RAPIDS, IA • BISMARCK, ND

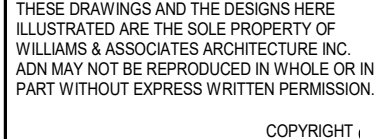

630 E Summit St, Lead, SD 57754

Revision Schedule

Verification Bar Scale: 1/8" = 1'-0"

PLEASE USE THIS BAR SCALE TO CONFIRM THAT THE DIGITAL OR HARDCOPY RE-PRODUCTION OF THIS SHEET IS AT THE CORRECT SCALE.



0 2 4 8

E3.10
